

FORNICE, PLATT EAGAN, YOUNGENTON
 MONTGOMERY COUNTY, MARYLAND
FORTUNE PARK

DATE: 11/15/11
 DRAWN BY: [Name]
 CHECKED BY: [Name]
 SCALE: 1" = 40'


LIGHTING LOCATION PLAN

NO.	DATE	BY	DESCRIPTION
1	11/15/11	[Name]	ISSUED FOR PERMIT
2			
3			
4			

L5.1

LANDSCAPE SITE

NOTE: ANY VARIATION OF PLAN TO BE APPROVED BY M-CHOPING STAFF
 RESIDENTIAL BUILDINGS TO BE EQUIPPED WITH A HOUSEHOLD LIGHTING PLAN
 NOTE: ALL LIGHTS IN COMMON AREAS SHALL BE EQUIPPED WITH A HOUSEHOLD LIGHTING PLAN

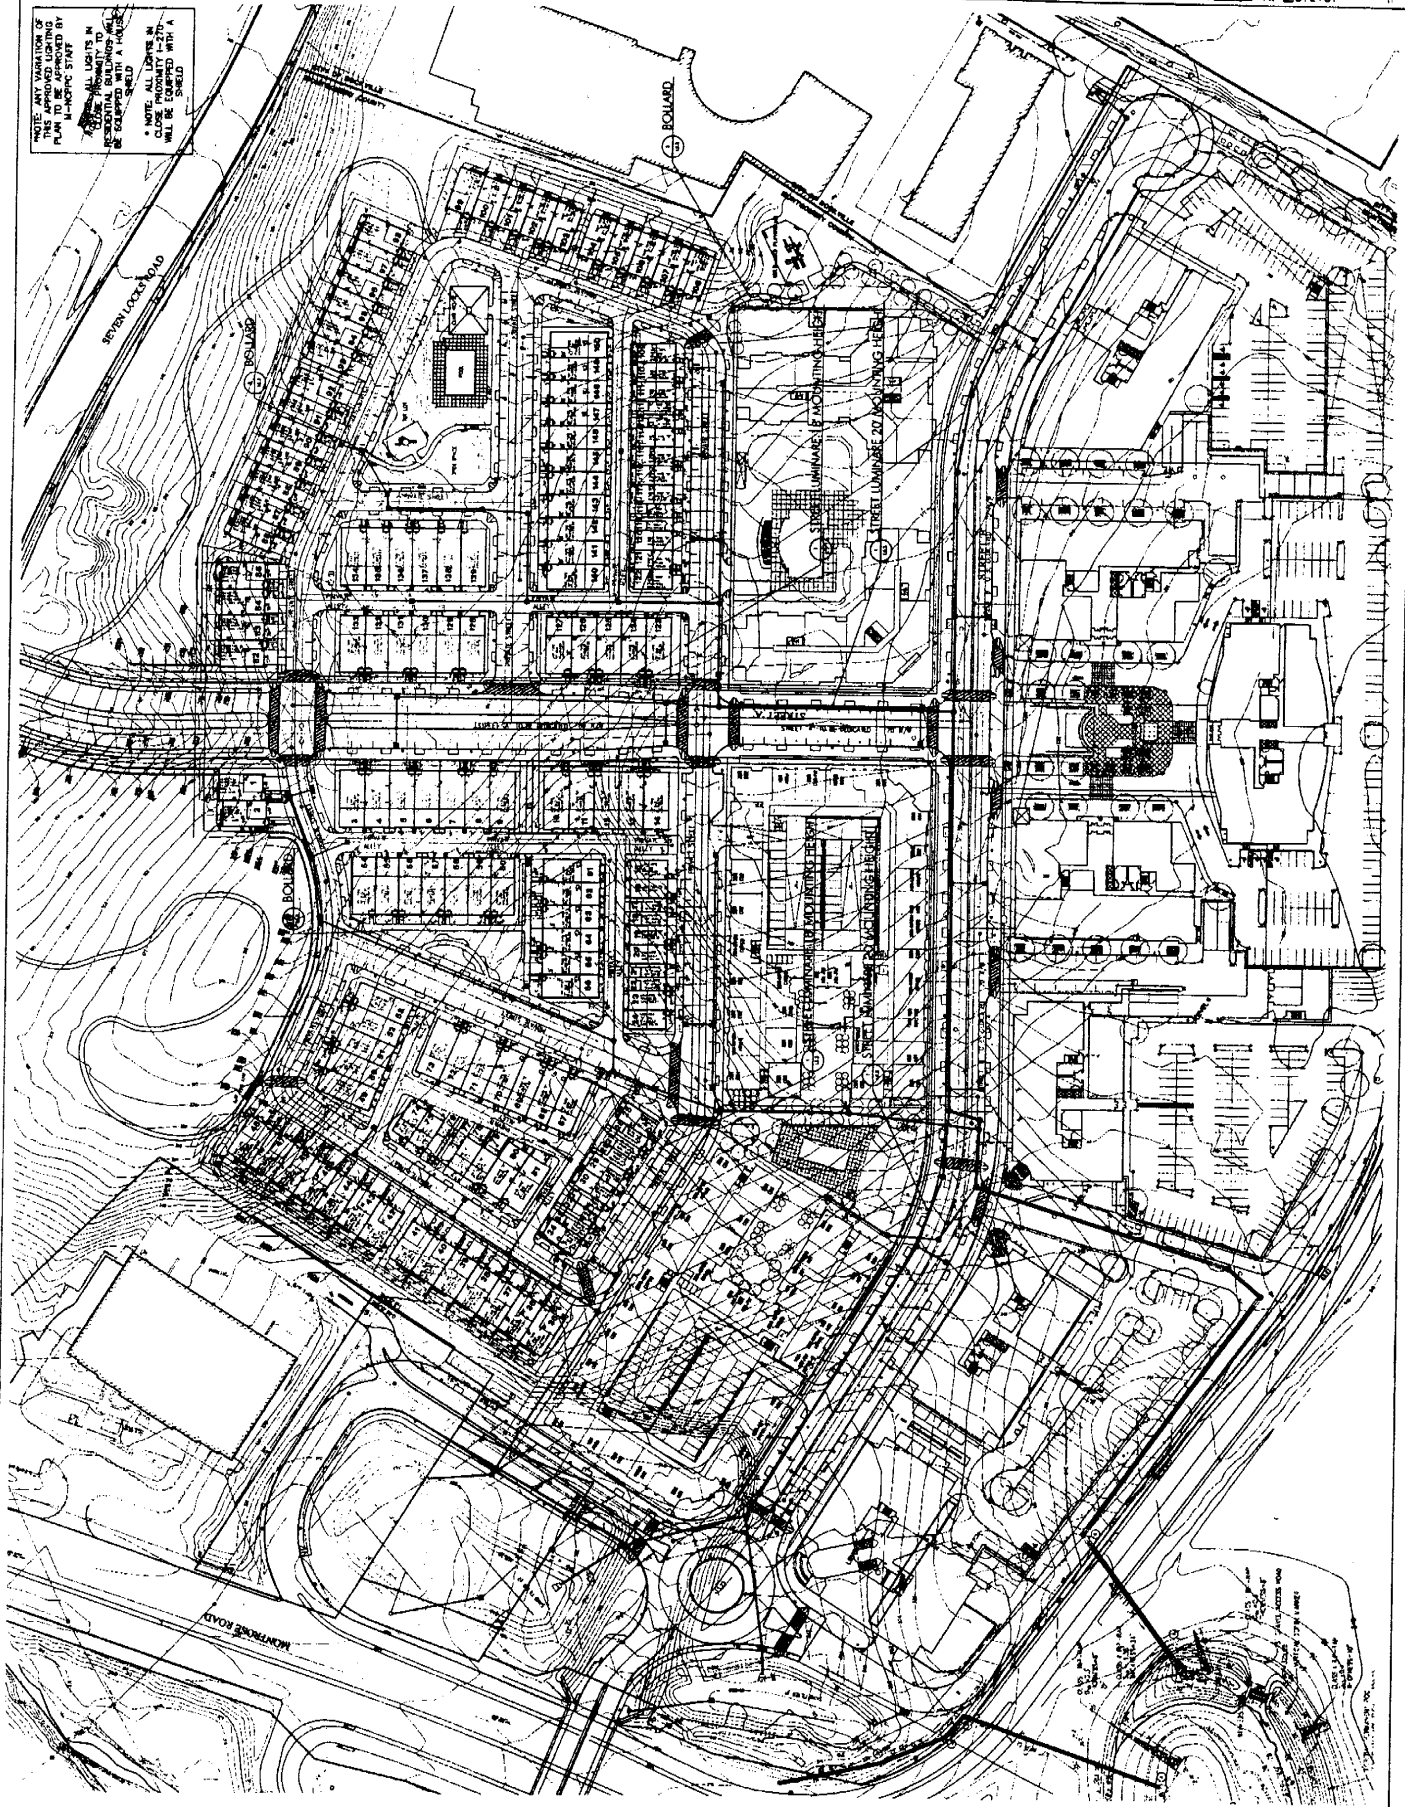


DATE: 11/11/2010
 PROJECT NO: 100000000
 SCALE: 1" = 100'-0"

DESIGNED BY: [Signature]
 CHECKED BY: [Signature]
 DATE: 11/11/2010

PROJECT: FORTUNE PARC
 LOCATION: MONTGOMERY COUNTY, MARYLAND
 CLIENT: FORTUNE REALTY



FORTUNE PARC
 MONTGOMERY COUNTY, MARYLAND
 FORTUNE REALTY EARTH FOUNDATION

NOTE: ANY VARIATION OF THIS PLAN TO BE APPROVED BY THE M-DCOPIC STAFF. ALL LIGHTS IN THIS PLAN SHALL BE EQUIPPED WITH A SHIELD. ALL LIGHTS IN THIS PLAN SHALL BE EQUIPPED WITH A SHIELD.

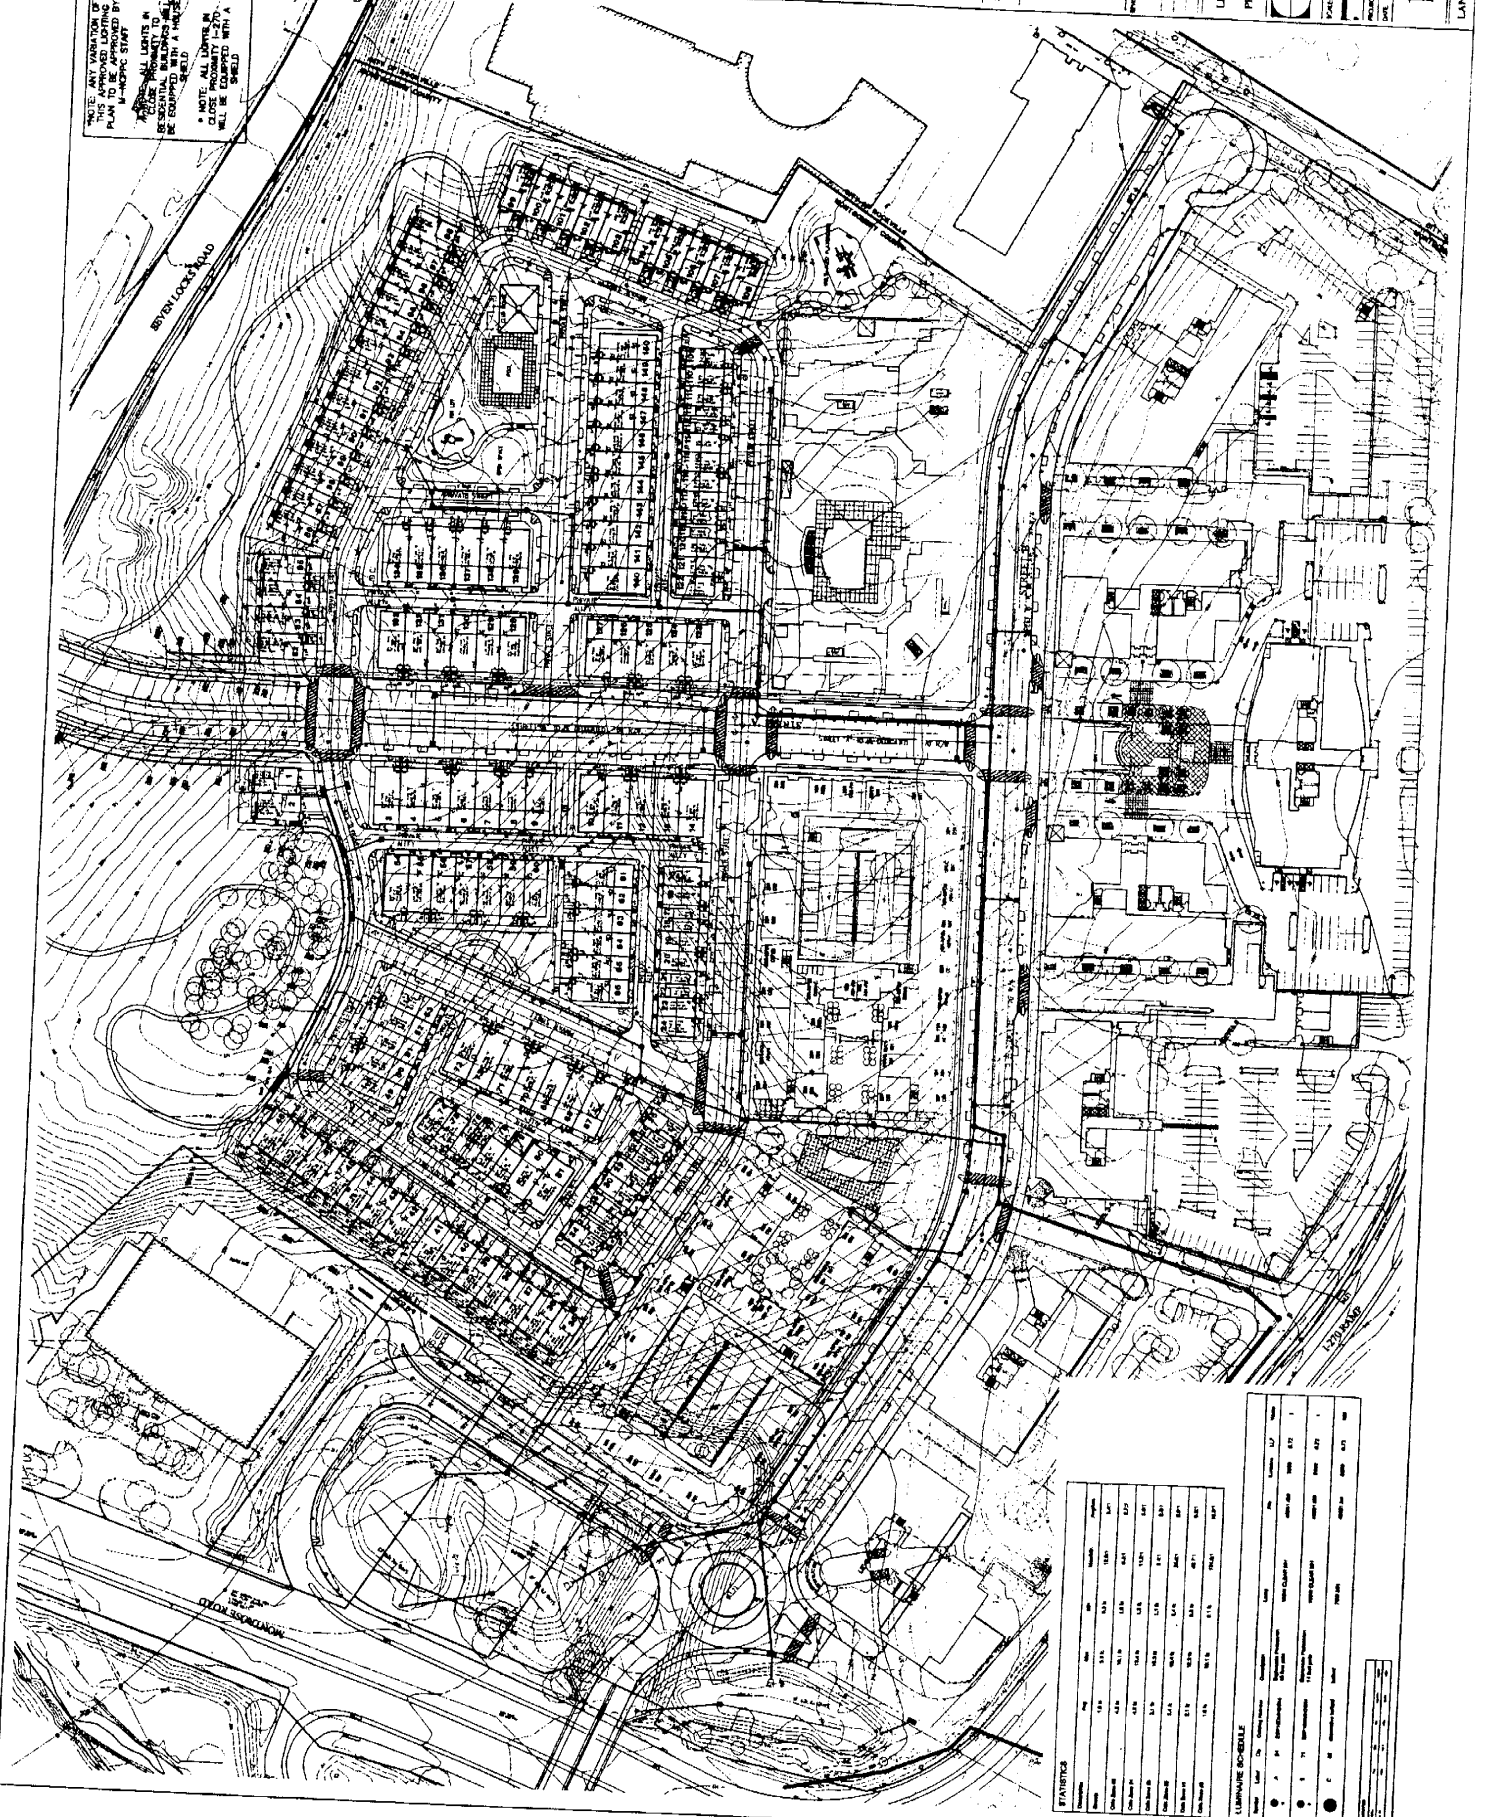

ITEM	QUANTITY	UNIT	DESCRIPTION
1	100	FT	100' HPS
2	150	FT	150' HPS
3	200	FT	200' HPS
4	250	FT	250' HPS
5	300	FT	300' HPS
6	350	FT	350' HPS
7	400	FT	400' HPS
8	450	FT	450' HPS
9	500	FT	500' HPS
10	550	FT	550' HPS
11	600	FT	600' HPS
12	650	FT	650' HPS
13	700	FT	700' HPS
14	750	FT	750' HPS
15	800	FT	800' HPS
16	850	FT	850' HPS
17	900	FT	900' HPS
18	950	FT	950' HPS
19	1000	FT	1000' HPS

 LANDSCAPE SCHEDULE
 1. 100' HPS
 2. 150' HPS
 3. 200' HPS
 4. 250' HPS
 5. 300' HPS
 6. 350' HPS
 7. 400' HPS
 8. 450' HPS
 9. 500' HPS
 10. 550' HPS
 11. 600' HPS
 12. 650' HPS
 13. 700' HPS
 14. 750' HPS
 15. 800' HPS
 16. 850' HPS
 17. 900' HPS
 18. 950' HPS
 19. 1000' HPS

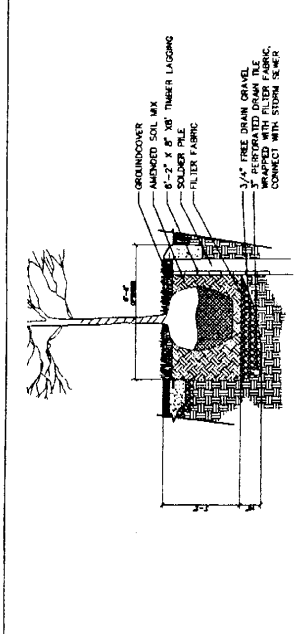

11 PUBLIC STREET TREE WELL
Scale: 1/8" = 1'-0"

CLASSIC RAIL SPECIFICATIONS
MODEL: MS 13
MANUFACTURER: P.O. BOX 887
FARMINGTON, MD 21040
TEL: 410-326-3318
WWW.POLYMER.COM
MIN. USE ZONE: 54' x 37'



PER PLAN TO BE SPECIFIED BY LANDSCAPE ARCHITECT
NOTE: INSTALLED PER MANUFACTURER'S RECOMMENDATIONS



12 MULTILAGED PLAYGROUND
Scale: 1/8" = 1'-0"

TOTILOT SPECIFICATIONS
MODEL: 714-538
MANUFACTURER: P.O. BOX 420
COLUMBIANA, MISSISSIPPI
TEL: 601-553-4022
WWW.MULCH-RECREATION.COM
STRUCTURING: 21' x 23'
MIN. USE ZONE: 34' x 37'


PER PLAN TO BE SPECIFIED BY LANDSCAPE ARCHITECT
NOTE: INSTALLED PER MANUFACTURER'S RECOMMENDATIONS

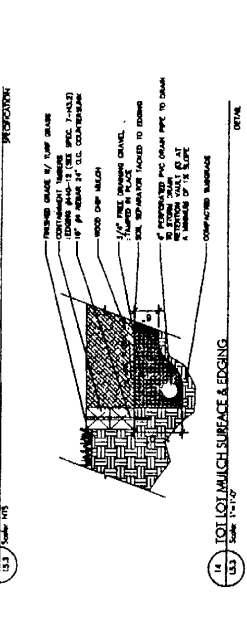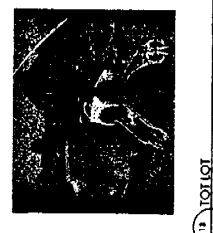


14 TOTILOT MULCH SURFACE & EDGING
Scale: 1/8" = 1'-0"

BIKE RACK TYPE
Scale: N.T.S.

RECYCLE BIN SPECIFICATIONS
MODEL: BR-2
MANUFACTURER: HANOVER, VA
QUANTITY: PER PLAN
COLOR: BLACK
NOTE: HANGERS TO PERMIT USE MANUFACTURER'S RECOMMENDATIONS

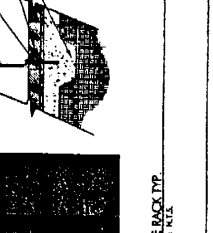


15 BIKE RACK TYPE
Scale: N.T.S.

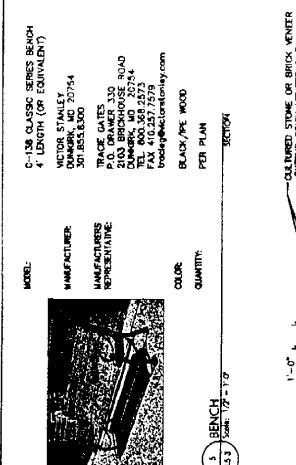


3 BENCH
Scale: 1/8" = 1'-0"

RETAINING WALL
Scale: 1/8" = 1'-0"


1-1/2" 3/4" FREE DRAINING GRAVEL
EXTENDING BELOW GRADE
REINFORCED CONCRETE
WEAP HOLES
1/4" FREE DRAINING GRAVEL
7" DIAL PERFORATED
PVC PIPE
FOUR-IN-PLACE
CONCRETE FOOTER
COMPACTED SUBGRADE

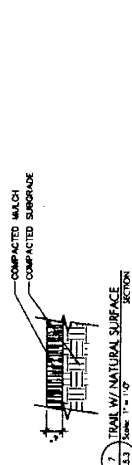


7 TRAIL WITH NATURAL SURFACE
Scale: 1/8" = 1'-0"

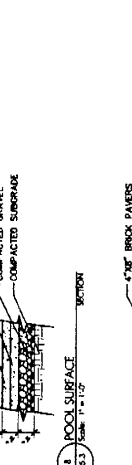


8 POOL SURFACE
Scale: 1/8" = 1'-0"

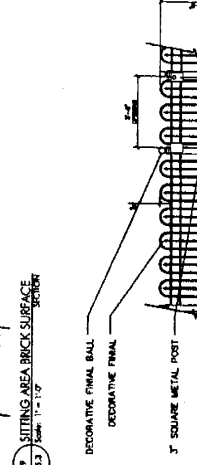

9 SITTING AREA BRICK SURFACE
Scale: 1/8" = 1'-0"

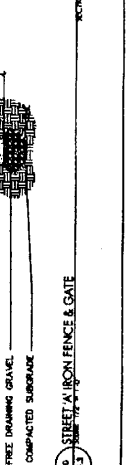

10 STREET WITH BRICK FENCE & GATE
Scale: 1/8" = 1'-0"

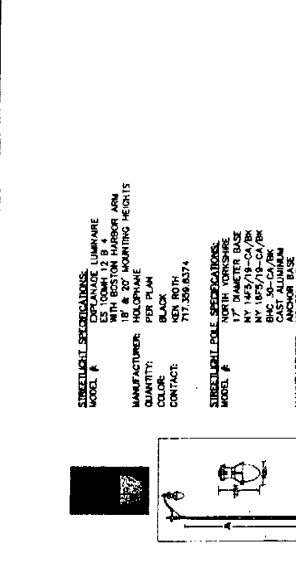

1 STREET LUMINAIRE AND POLE
Scale: 1/8" = 1'-0"

STREET LUMINAIRE SPECIFICATIONS
MODEL # 100H12 B 4
MANUFACTURER: HANOVER, VA
QUANTITY: PER PLAN
COLOR: BLACK
CONTACT: 717.258.8374

STREET LIGHT POLE SPECIFICATIONS
MODEL # 17
MANUFACTURER: HANOVER, VA
QUANTITY: PER PLAN
COLOR: BLACK
CONTACT: 717.258.8374



STREET LIGHT SPECIFICATIONS
MODEL # 30
MOUNTING HEIGHT: 30'
MANUFACTURER: HANOVER, VA
QUANTITY: PER PLAN
COLOR: BLACK
CONTACT: 717.258.8374



2 PARKING LOT LUMINAIRE AND POLE
Scale: 1/8" = 1'-0"

FARMING LOT/STREET LIGHT SPECIFICATIONS
MODEL: 48-112/120/120/120/120/120
MANUFACTURER: HANOVER, VA
QUANTITY: PER PLAN
COLOR: BLACK
NOTE: INSTALLED PER MANUFACTURER'S RECOMMENDATIONS


MANUFACTURER: COMMERCE SALES, INC.
897 DORSET ROAD
ELIZABETH, MARYLAND 21075
(301) 681-1650
PER PLAN
COLOR: BLACK
NOTE: INSTALLED PER MANUFACTURER'S RECOMMENDATIONS

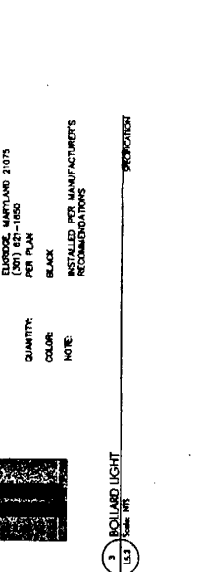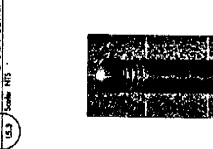


3 BOLLARD LIGHT
Scale: 1/8" = 1'-0"

BOLLARD LIGHT ANCHORING
Scale: 1/8" = 1'-0"


REINFORCED ANCHOR BOLT FOR MANUFACTURER'S SPECIFICATION
FIBERED GRADE
FOUR-IN-PLACE CONCRETE TYPING

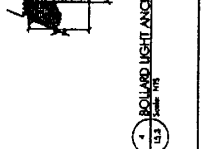

4 BOLLARD LIGHT ANCHORING
Scale: 1/8" = 1'-0"

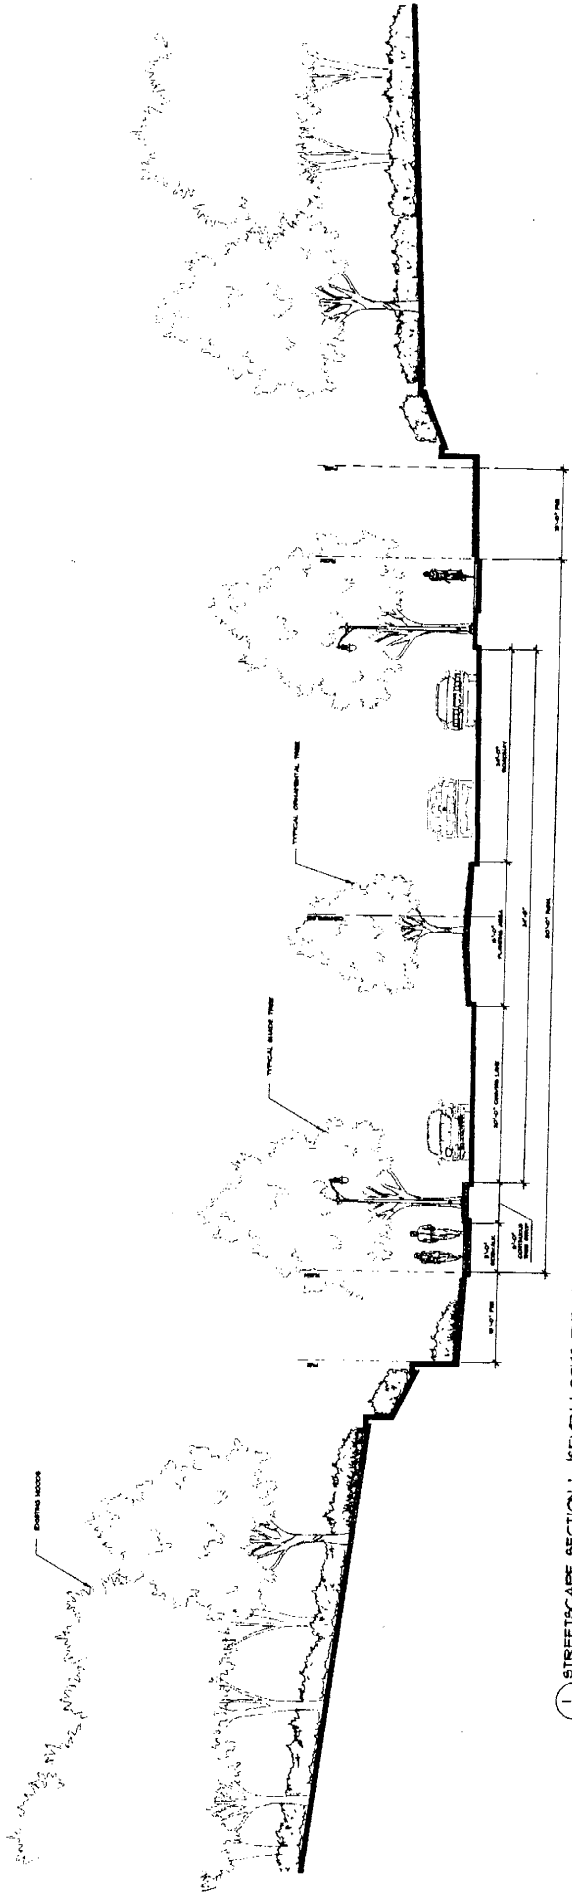



1. STREETScape SECTION 1 SEVEN LOCKS ENTRANCE DRIVE
SCALE: 3/8" = 1'-0"

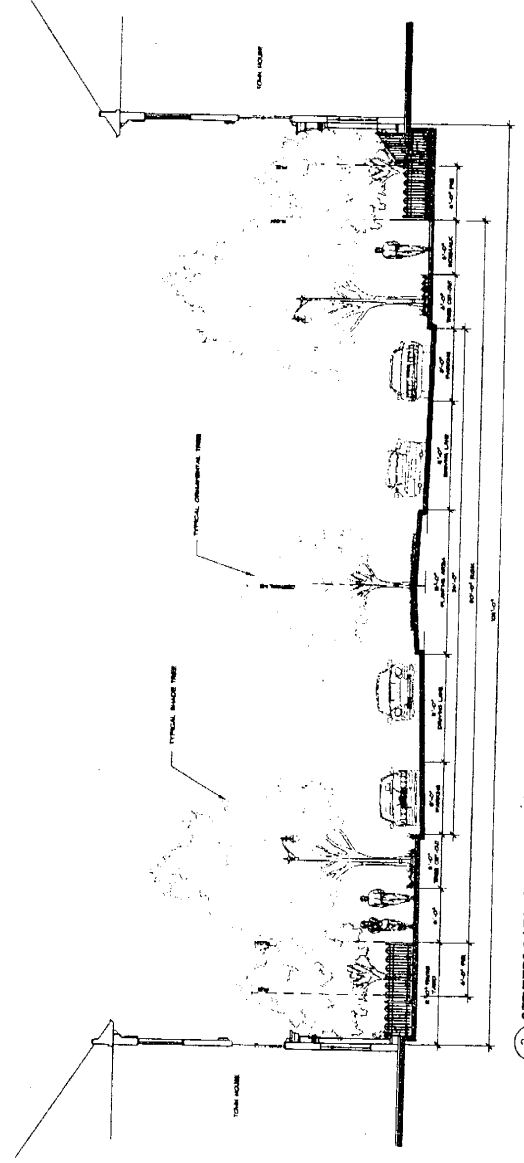

2. STREETScape SECTION 2 MAIN ROAD WITH MEDIAN
SCALE: 3/8" = 1'-0"

STREETScape SECTIONS FORTUNE PARK MONTGOMERY COUNTY, MARYLAND		DRAWN BY: [] CHECKED BY: [] DATE: []
PROJECT NO.: [] SHEET NO.: [] OF []	DESIGNER: [] CLIENT: [] DATE: []	SCALE: [] TITLE: []

THIS DRAWING IS
ILLUSTRATIVE PURPOSES ONLY

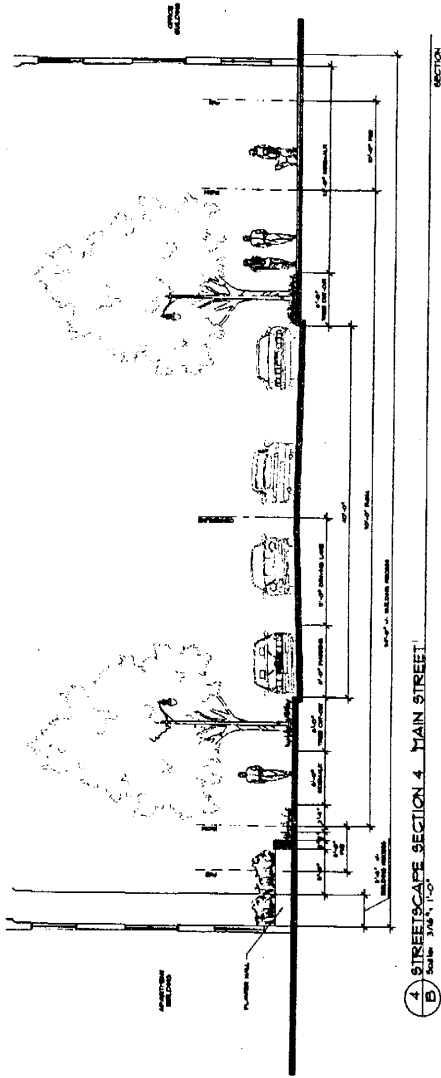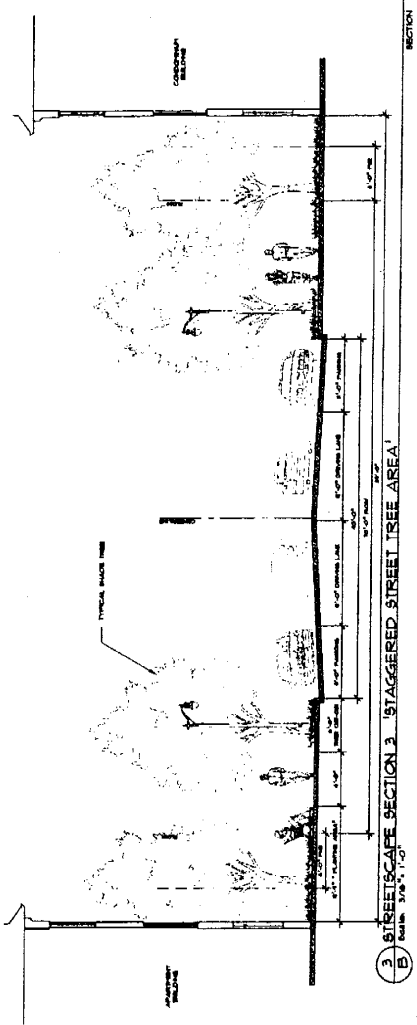

STREETScape SECTIONS FORTUNE PARK MONTGOMERY COUNTY, MARYLAND		DATE: 3/14/10
DESIGNED BY: CONSTRUCTION, INC.	PROJECT NO.: 100000000	DATE: 3/14/10
DRAWN BY: MADON/CONSTRUCTION	PROJECT NO.: 100000000	DATE: 3/14/10
CHECKED BY: MADON/CONSTRUCTION	PROJECT NO.: 100000000	DATE: 3/14/10
DATE: 3/14/10	PROJECT NO.: 100000000	DATE: 3/14/10

THIS DRAWING IS FOR
 ILLUSTRATIVE PURPOSES ONLY.